



DEWHURST B

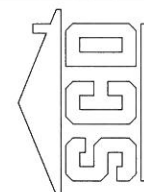






DENNIS ARMSTRONG
 P.O. BOX 121
 MILNER GA. 30251
 PHONE T70-358-1438
 FAX T70-358-2161

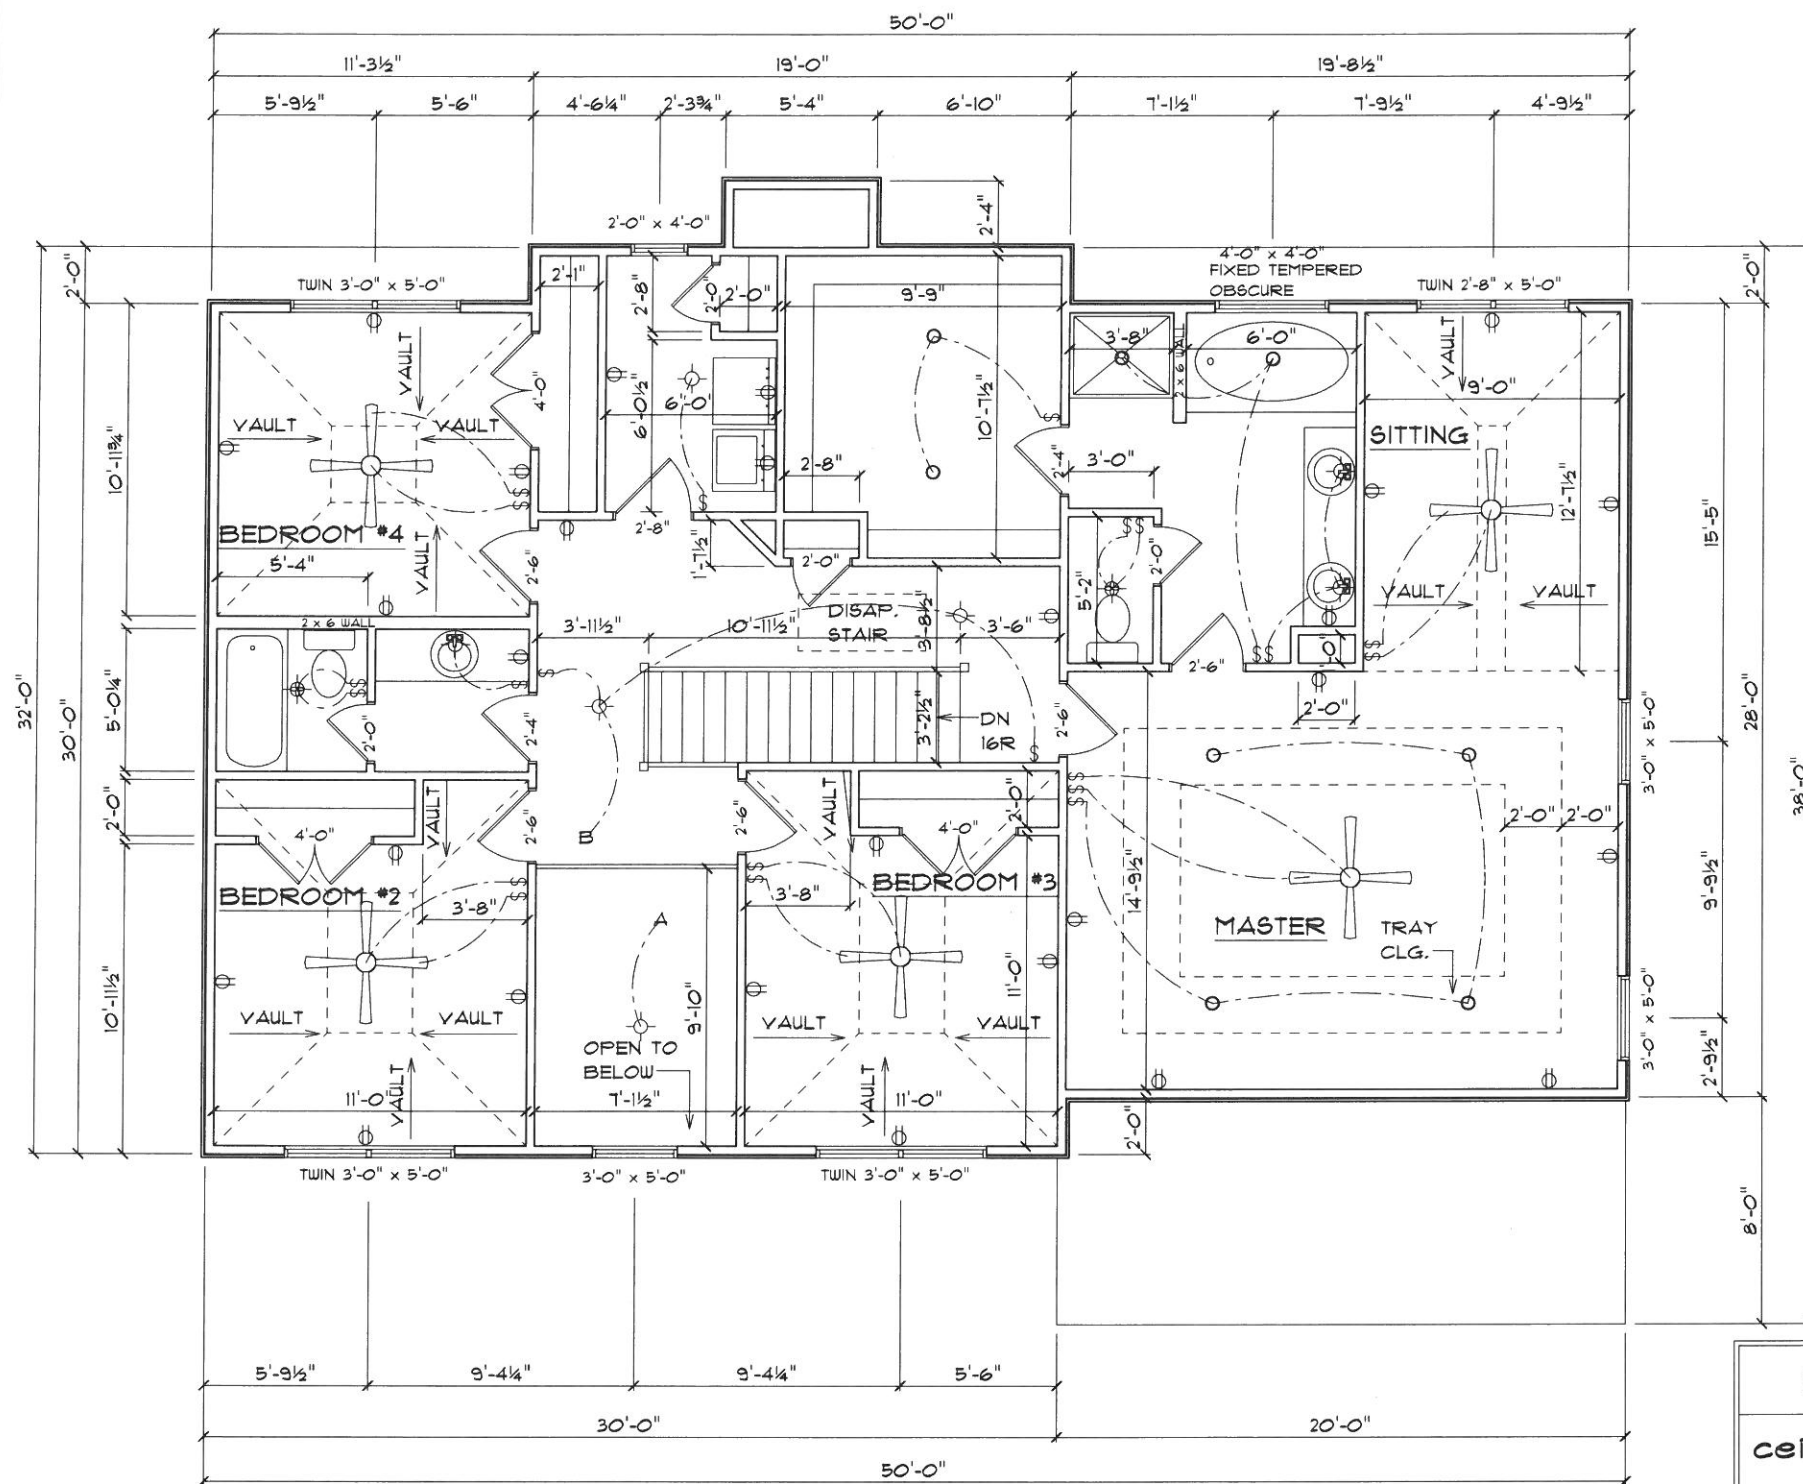

JOB NUMBER:
16-009

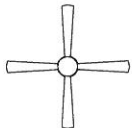

2ND FLOOR PLAN
 SCALE: 1/4" = 1'-0"

ELECTRICAL	COUNT	SYMBOL
ceiling fan globe 1	5	
pot light	8	
fan light combo	2	
light	7	
outlet	27	
switch	22	